








**Legend:**

-  Proposed footpath
-  Proposed gully
-  Existing hedgerow to be maintained
-  Proposed piping of drain

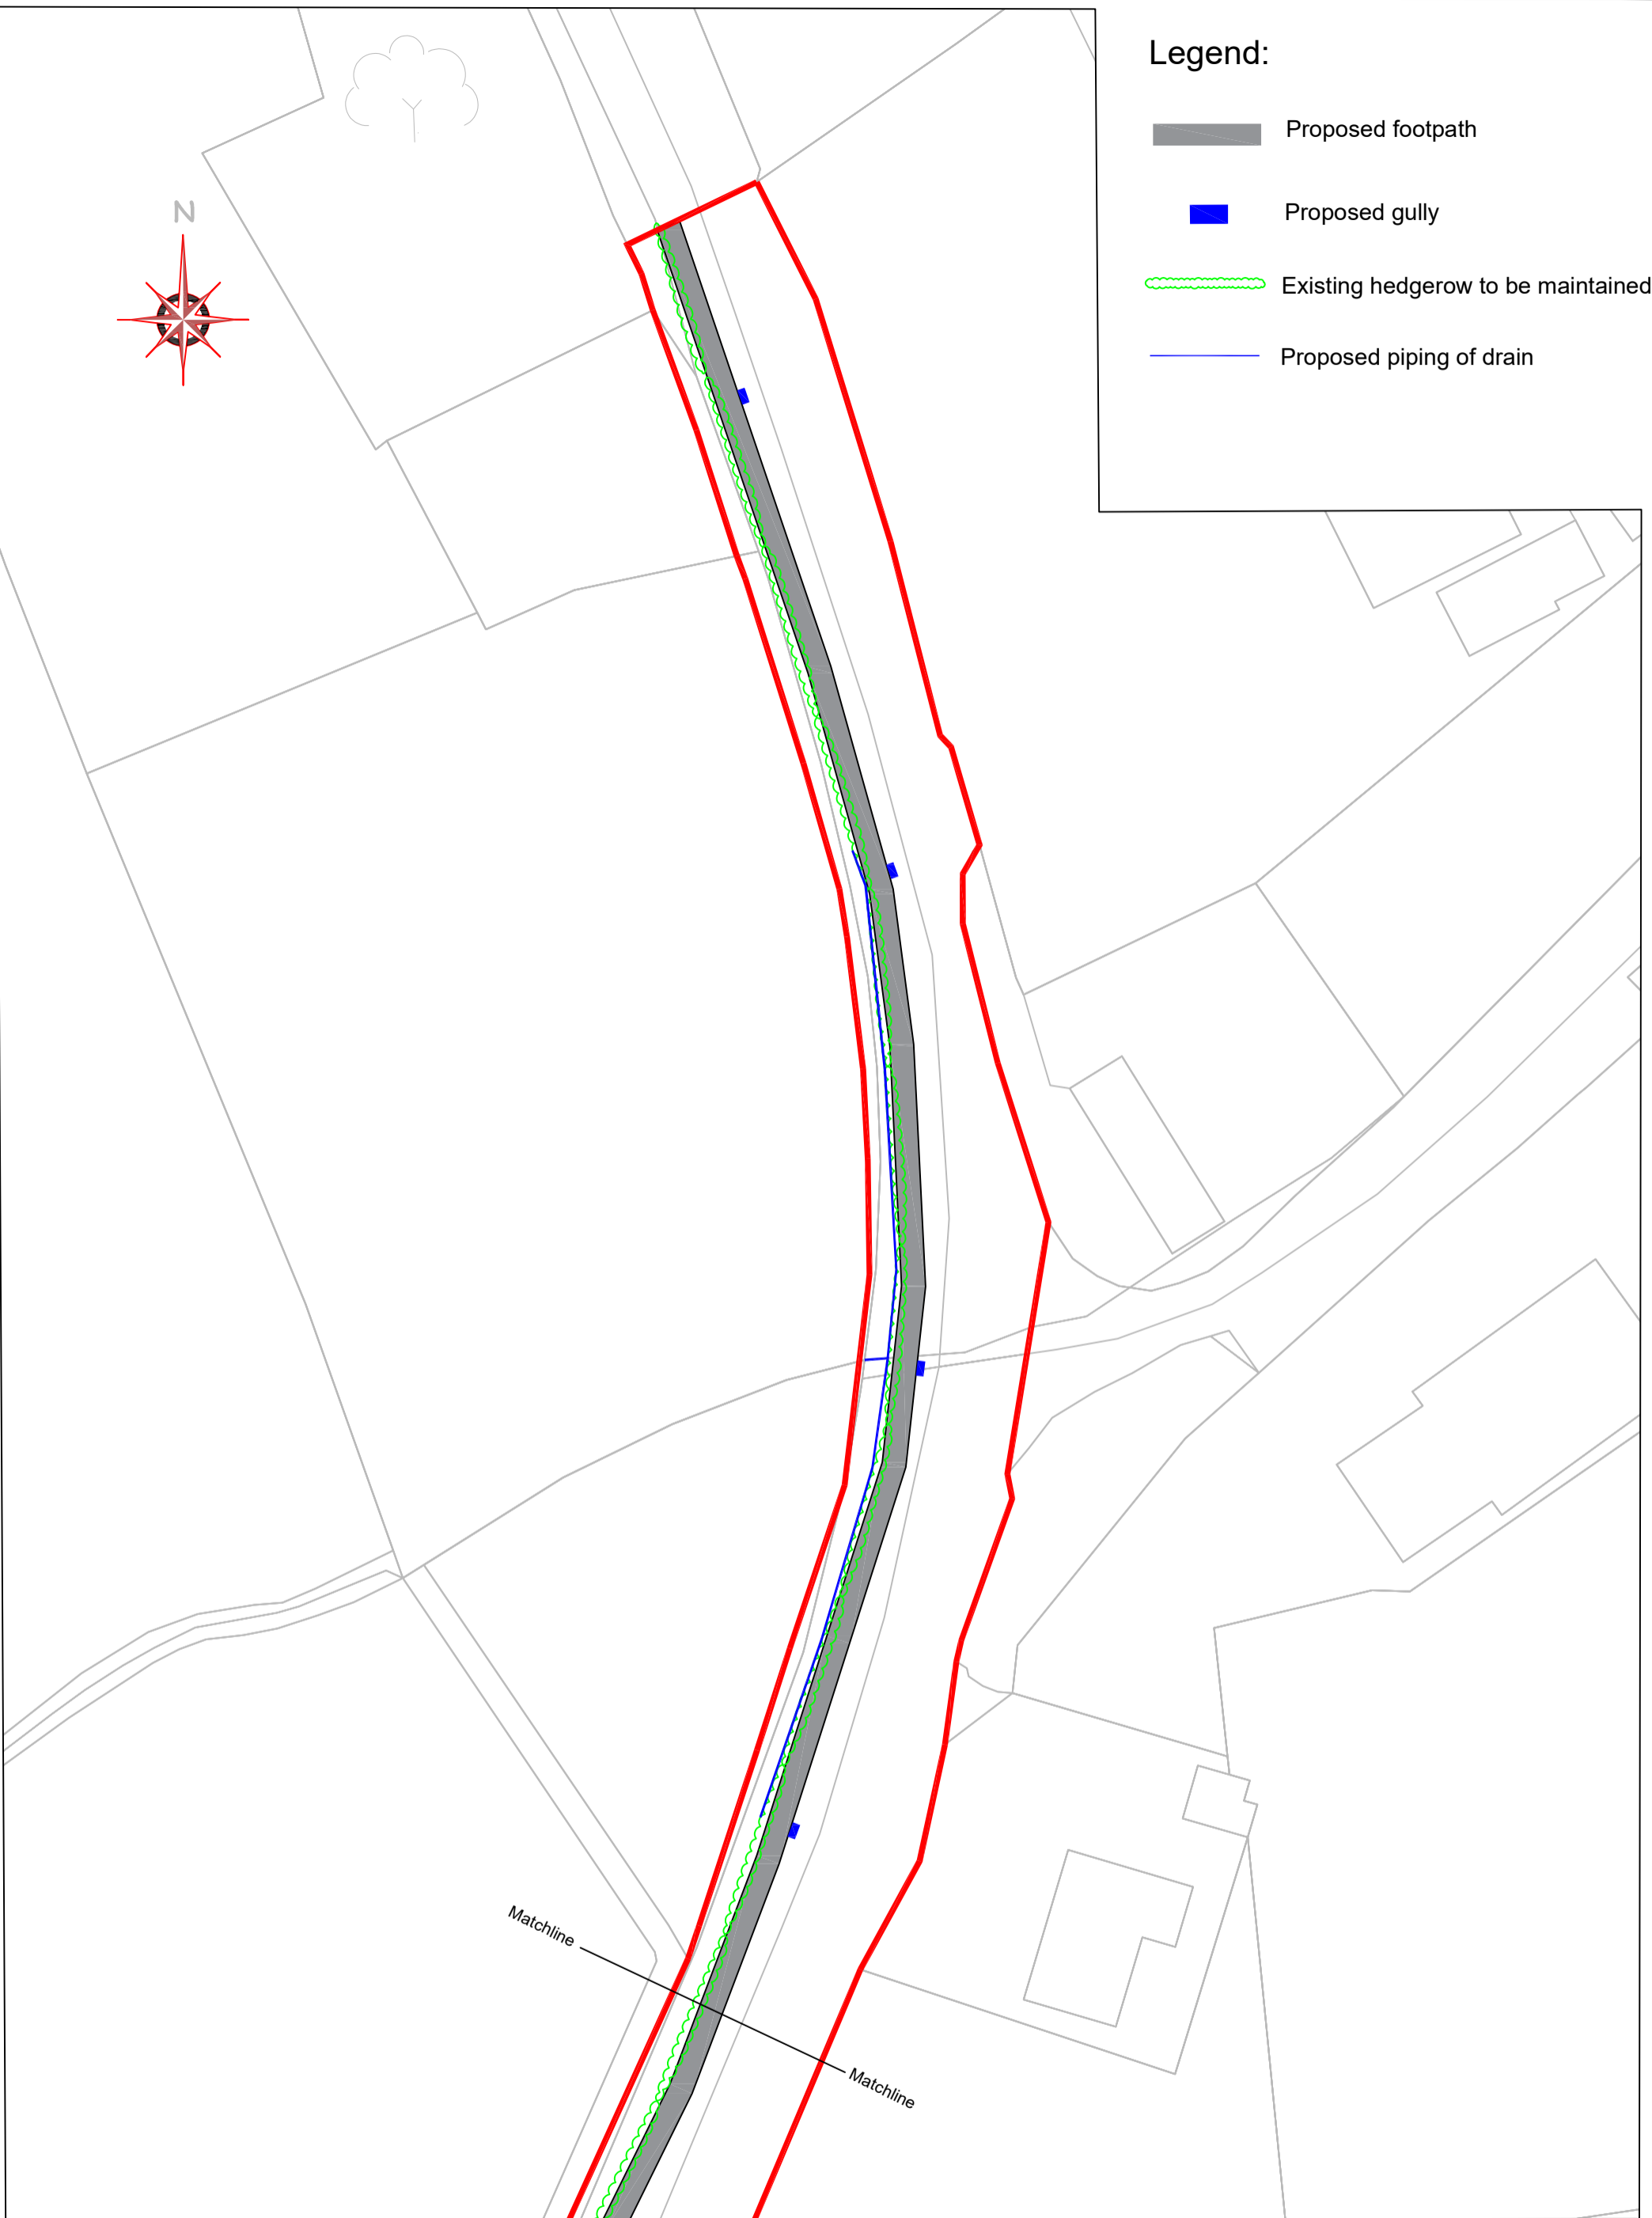

**Leitrim County Council**

Director of Services  
Mr. Joseph Gilhooly  
Áras an Chontae  
Carrick-on-Shannon  
Co. Leitrim  
Tel: 071 9620005

|   |                           |   |                                  |                       |
|---|---------------------------|---|----------------------------------|-----------------------|
| <i>Project</i><br>Rooskey T&V Scheme - Proposed Footpath Scheme |                           |   |                                  |                       |
| <i>Component</i><br>Map   |                           | <i>Title</i><br>Drainage Layout                 |                                  |                       |
| <i>Scales</i><br>1:500 @A3                                      | <i>Date</i><br>22/06/2022 | <i>O.S. Sheet Ref.:</i><br>1987-C,2046-A,2046-C | <i>Drawing No.:</i><br>RTV-004.2 | <i>Revision:</i><br>0 |
| <i>Design</i><br>RF   | <i>Drawn</i><br>RF        | <i>Checked</i><br>PMS                           |                                  |                       |